




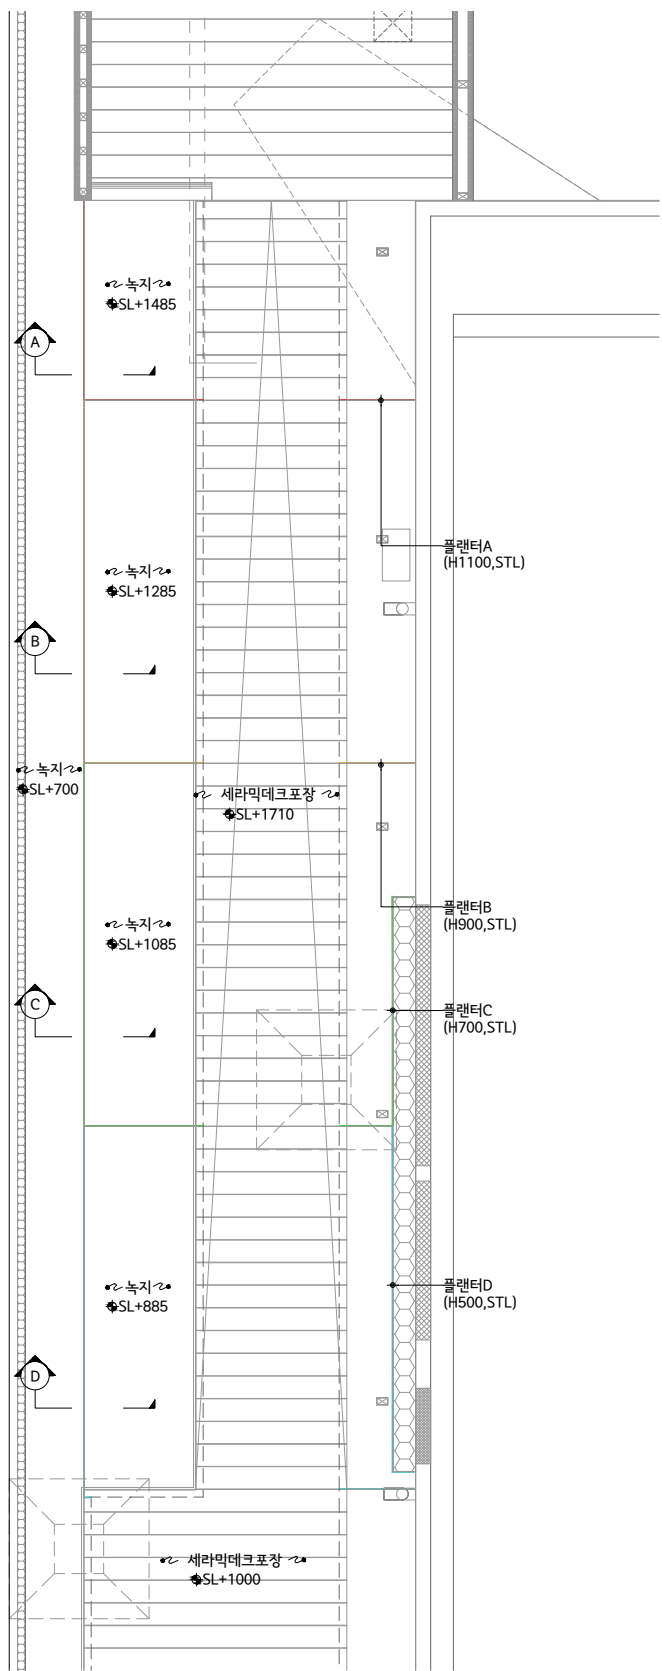


1 플랜터A,B,C,D평면도
SCALE=A1:1/50
A3:1/100

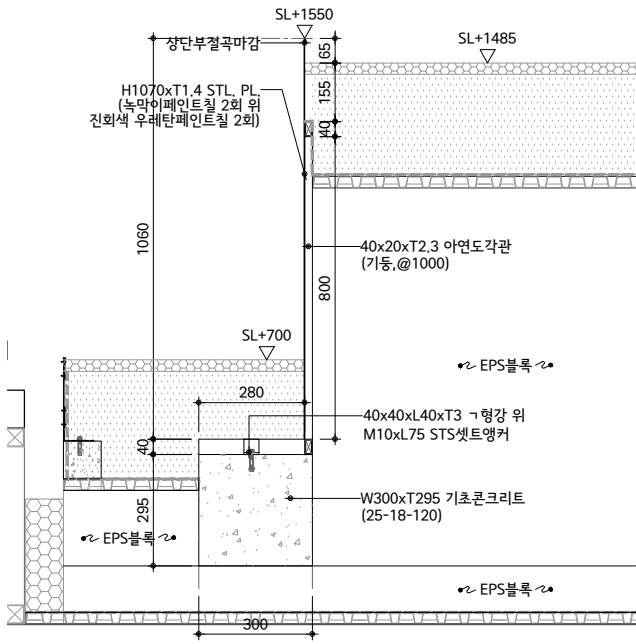


2 플랜터A단면도
SCALE=A1:1/10
A3:1/20

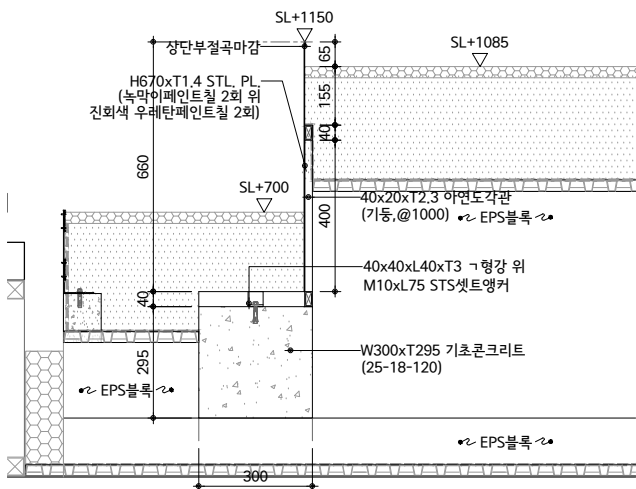

3 플랜터C단면도
SCALE=A1:1/10
A3:1/20

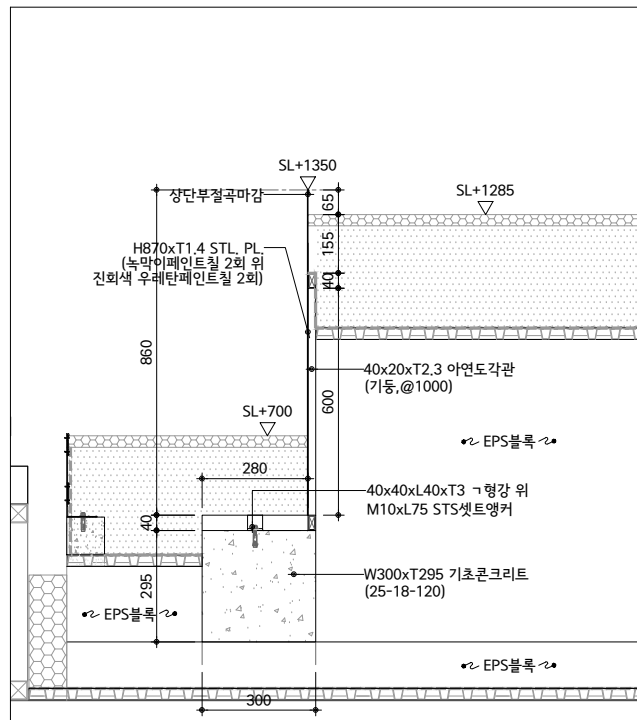


3 플랜터B단면도
SCALE=A1:1/10
A3:1/20

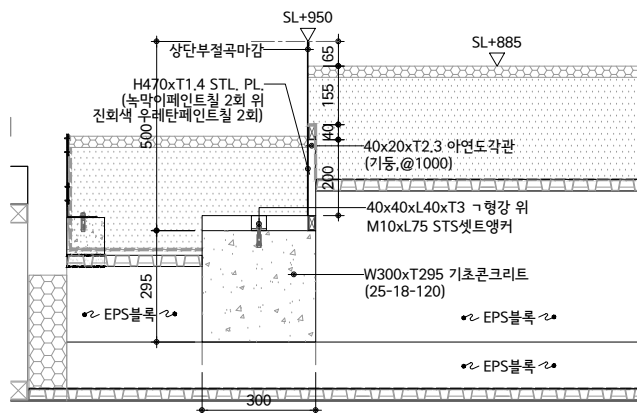


4 플랜터D단면도
SCALE=A1:1/10
A3:1/20

PROJECT TITLE

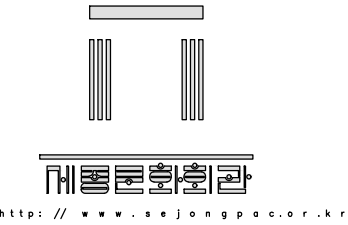

세종문화회관
시설현황도

NOTES

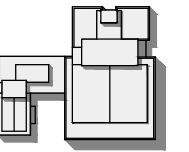

ARCHITECTS

CONSULTANTS
STRUCTURAL

MECHANICAL

ELECTRICAL

CIVIL

REVISION

REV.NO	DESCRIPTION	DATE
--------	-------------	------

APPROVED BY

REVIEWED BY

CHECKED BY

DRAWN BY

SCALE
A3 : 1/100,20

DRAWING TITLE

플랜터A,B,C,D상세도

DRAWING NO.

L-514

SHEET NO.

DATE 2026.07